


SYMBOL LEGEND

	PUBLIC TELEPHONE
	ELEC BOARD
	SUB ELEC DB'S
	TELEPHONE BOARD
	FIRE EXTINGUISHER/FIRE HOSE REEL
	FIRE EXTINGUISHER
	AIR CONDITIONING DUCT/ROOM
	PLUG POINT IN FLOOR

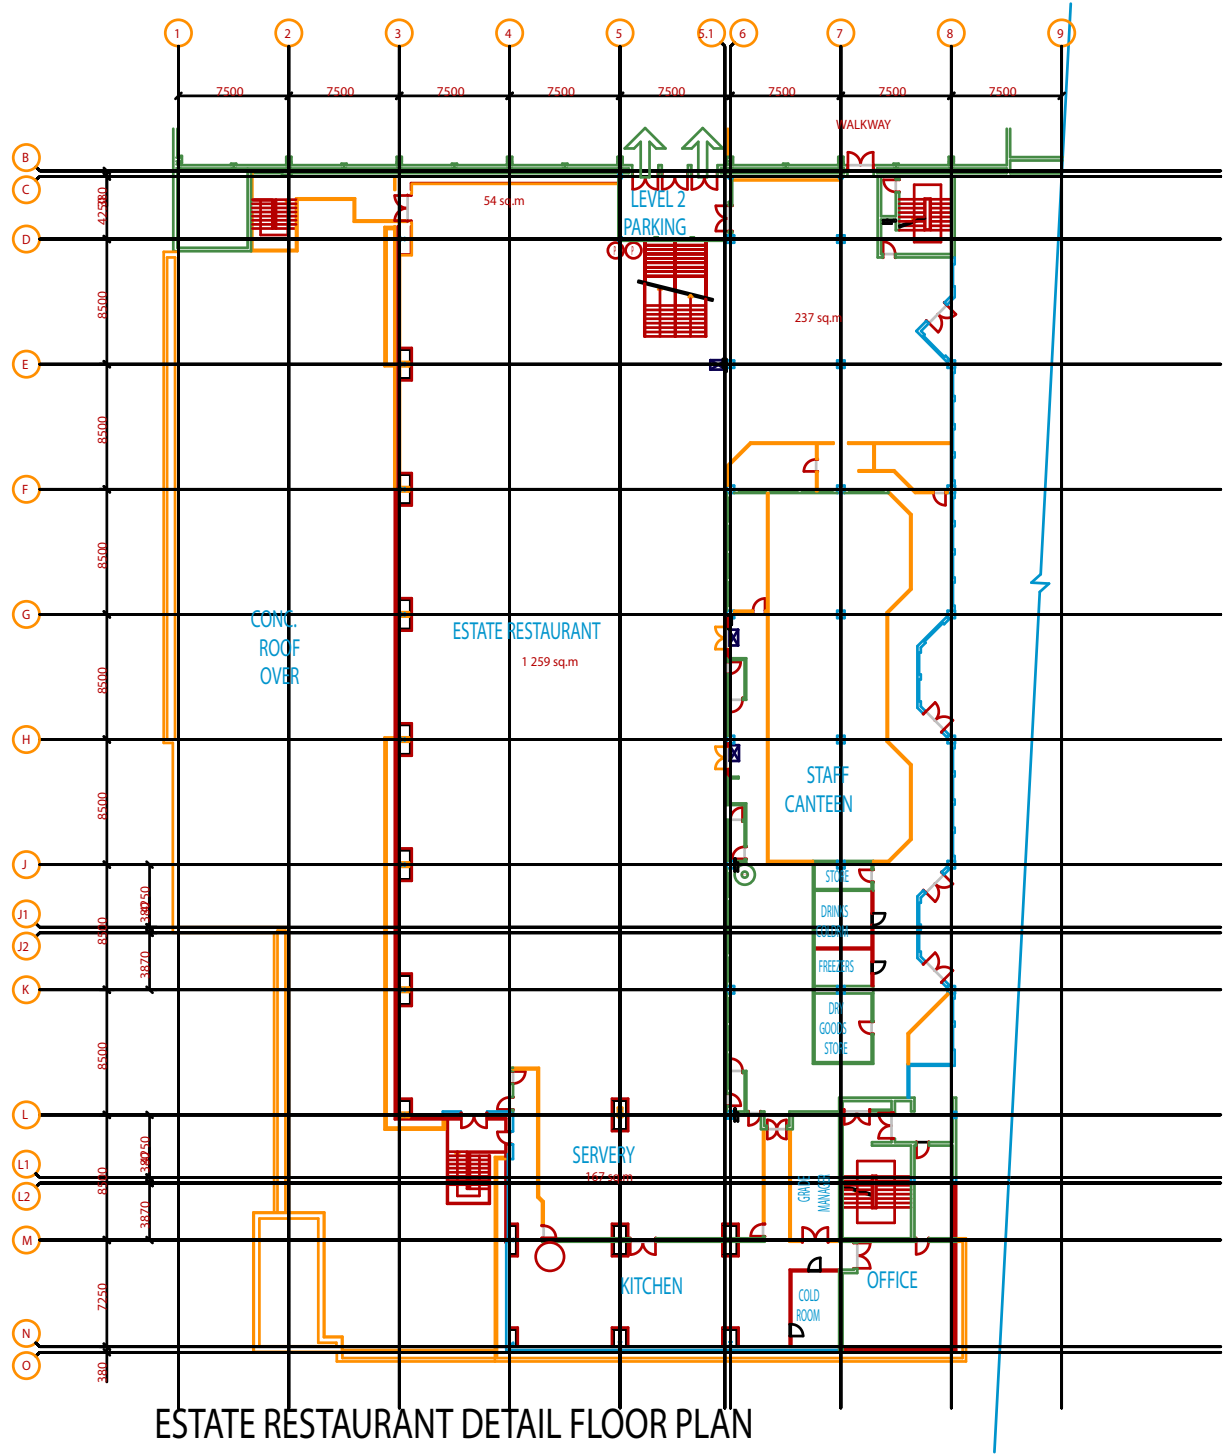

ESTATE RESTAURANT DETAIL FLOOR PLAN

SCALE 1:400

