


SYMBOL LEGEND

	PUBLIC TELEPHONE
	ELEC BOARD
	SUB ELEC DB'S
	TELEPHONE BOARD
	FIRE EXTINGUISHER/FIRE HOSE REEL
	FIRE EXTINGUISHER
	AIR CONDITIONING DUCT/ROOM
	PLUG POINT IN FLOOR

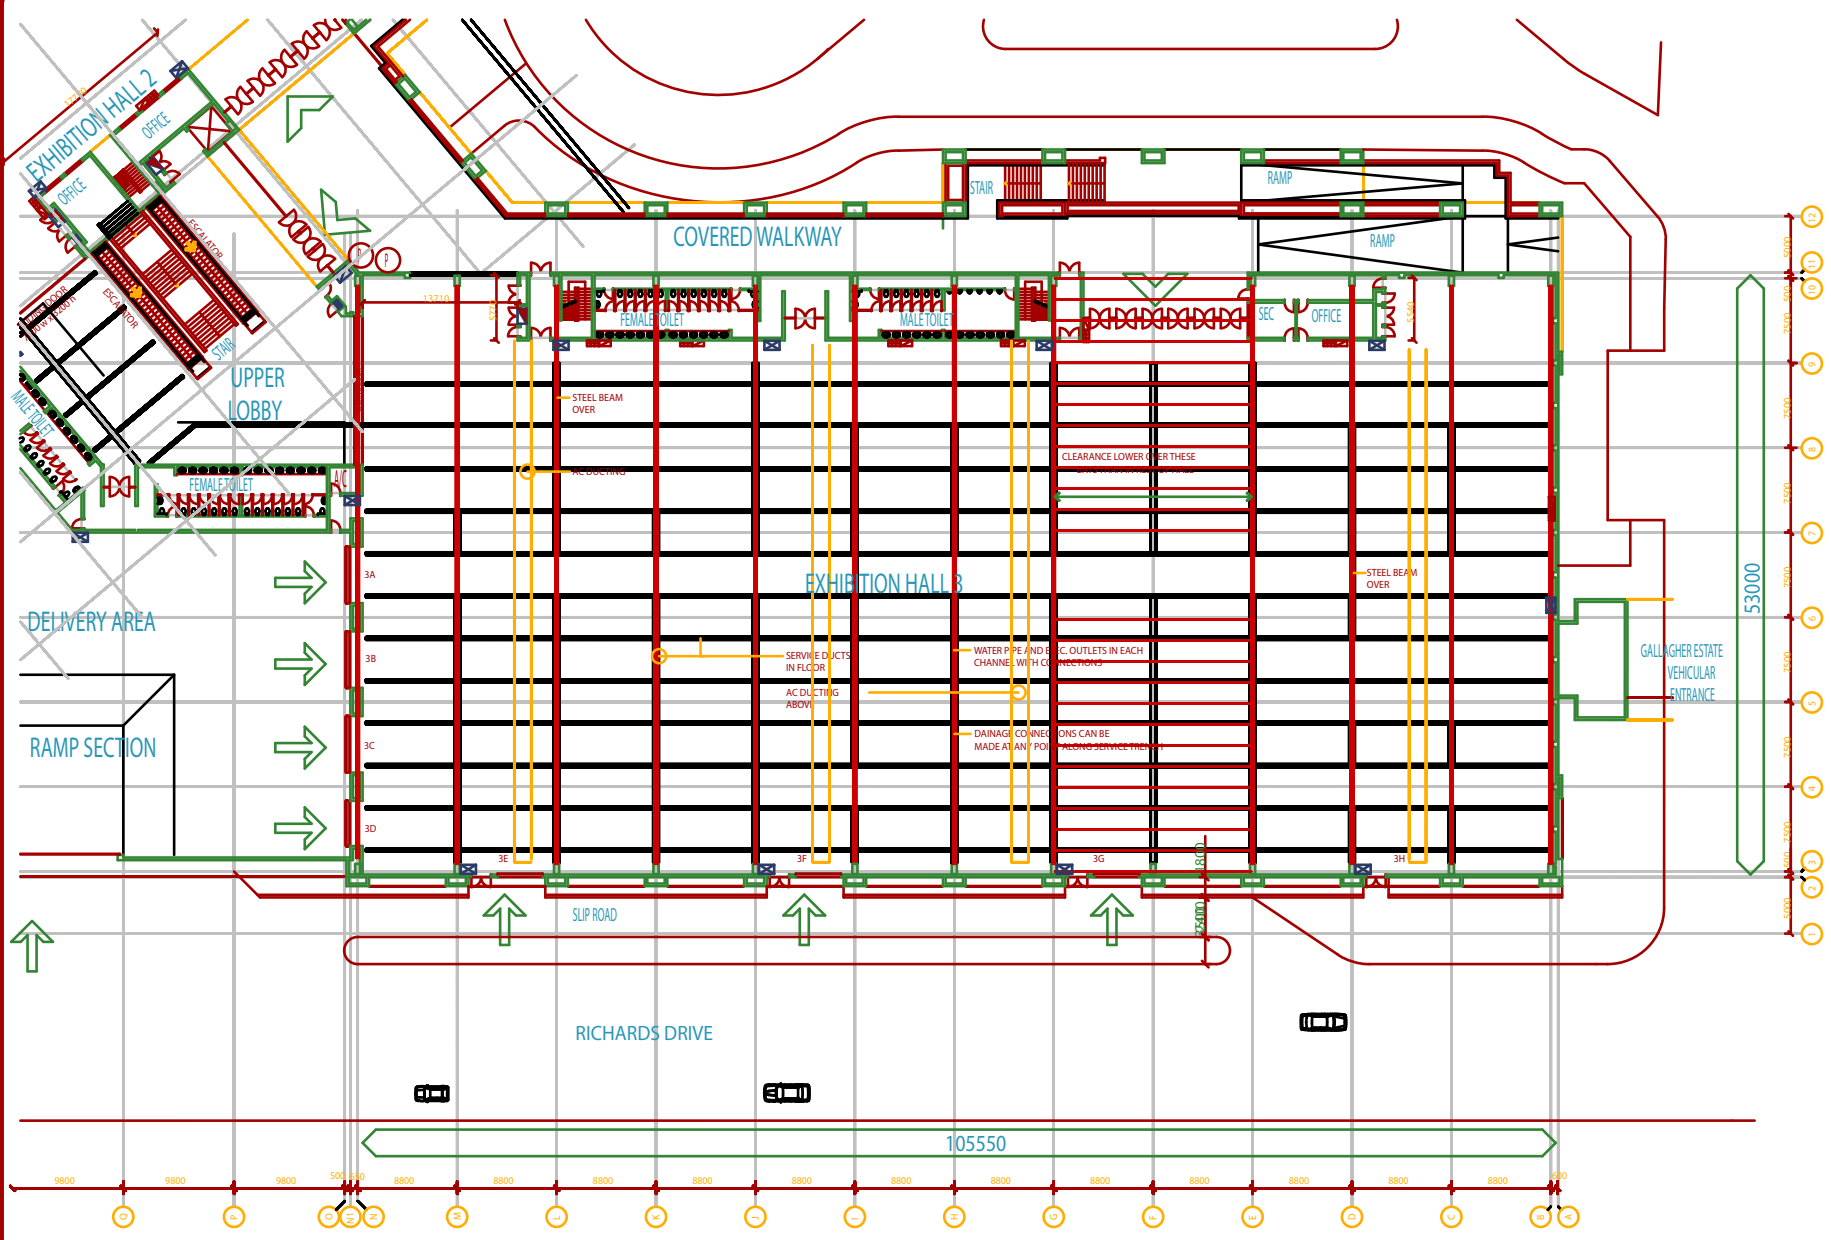

EXHIBITION HALL 3 - DETAIL FLOOR PLAN
 SCALE 1:500
 EXHIBITION HALLS 1, 2 & 3

